



LEGEND

- FIRE RESISTING
- K AUTOMATIC HEAT DETECTOR COVERAGE
- S AUTOMATIC SMOKE DETECTOR COVERAGE
- S22 → FIRE EXIT SYMBOL
- S22 ILLUMINATED FIRE EXIT SYMBOL
- S20 FIRE ESCAPE KEEP CLEAR
- S13 FIRE DOOR KEEP SHUT
- S14 FIRE DOOR KEEP LOCKED
- ESCAPE LIGHTING COVERAGE
- CARBON DIOXIDE EXTINGUISHER
- FOAM FIRE EXTINGUISHER
- FIRE ALARM CALL POINT
- SL SECURITY LOCK
- PB DOOR WITH PANIC BOLT
- SF DOOR WITH SIMPLE FASTENINGS ONLY

01 / GROUND FLOOR PLAN

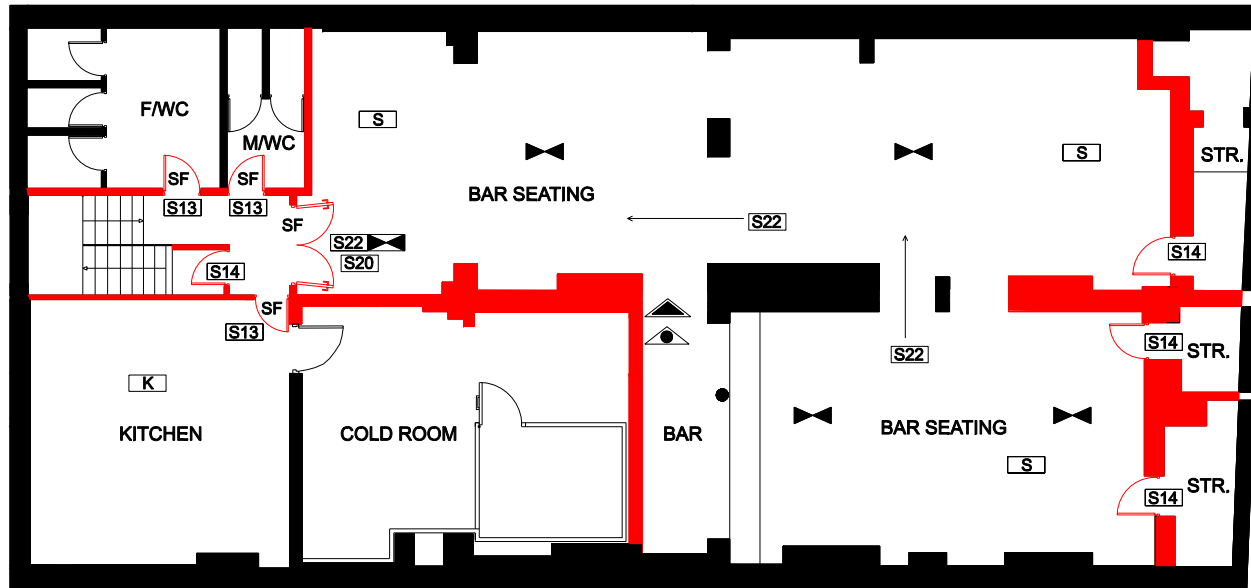

 02 / BASEMENT PLAN



Notes
Do not scale from this drawing.
All dimensions are to be checked on site and any discrepancies noted in writing to the Contract Administrator. All dimensions are in millimetres unless noted otherwise.
If in doubt ask the Contract Administrator.

Rev.	Date	Description	Drawn	Checked
00	00	00	00	00



Don Orke Architects Ltd
12, Imperial Road
London N22 6DE
Tel :020 3536 8507 mc0796 8778 635
www.do-a.co.uk

Client:
DREAM GROUP LTD

Job Title:
123-125 KINGSLAND HIGH STREET

Drawing Title:
FIRE DIAGRAM

Scale: 1:50 @ A1, 1:100 @ A3 Date: 04.08.20

Discipline: Architecture

Drawing Status: INFORMATION

Job No:	Drawing No:	Revision:
01888	TS01	